


ELEVATION LOOKING EAST

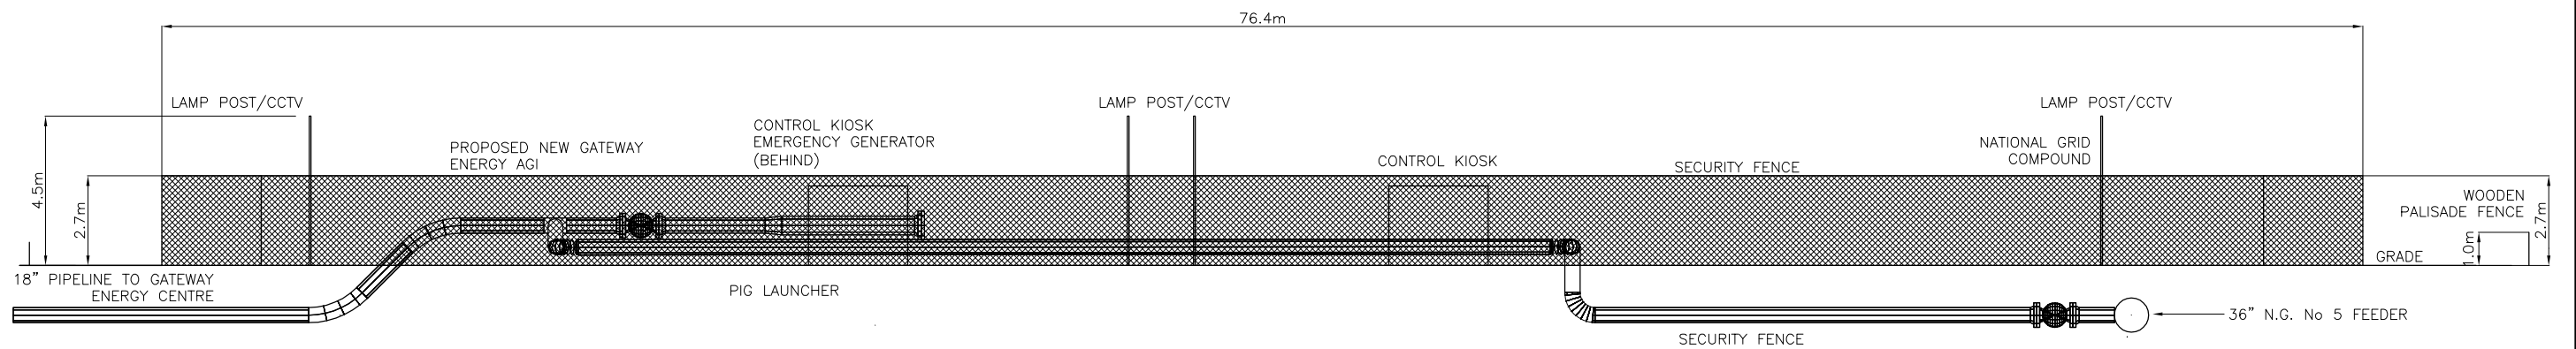

ELEVATION LOOKING SOUTH

This drawing is the sole property of IACS Corrosion Engineering Ltd. and should not be copied in total or any part thereof without prior written permission of the owner. Do not scale. If in doubt ask.

REV.	DR'N	DATE	CH'D	DATE	APP'D	DATE	REVISION COMMENTS	CLIENT	PROJECT
								 IACS Corrosion Engineering Ltd Hazelbank House, Downe Rd Keston BR2 6AD Tel: 01959 570011 Fax: 01959 573322	GATEWAY ENERGY PIPELINE INDICATIVE BUTTS LANE A.G.I. SOUTH & EAST ELEVATIONS
GEC-DWG-09-333-003	BUTTS LANE AGI GENERAL ARRANGEMENT	C	MF	17.03.11	PL	17.03.11	PL		
GEC-DWG-09-333-014	PIPING & INSTRUMENTATION DIAGRAM	B	MF	14.03.11	PL	14.03.11	PL	14.03.11	ISSUED FOR PLANNING PERMISSION
		A	MF	13.03.11	PL	13.03.11	PL	13.03.11	ISSUED FOR INTERNAL COMMENT
	REFERENCE DRAWINGS							FILE LOCATION:	SCALE: 1:100